
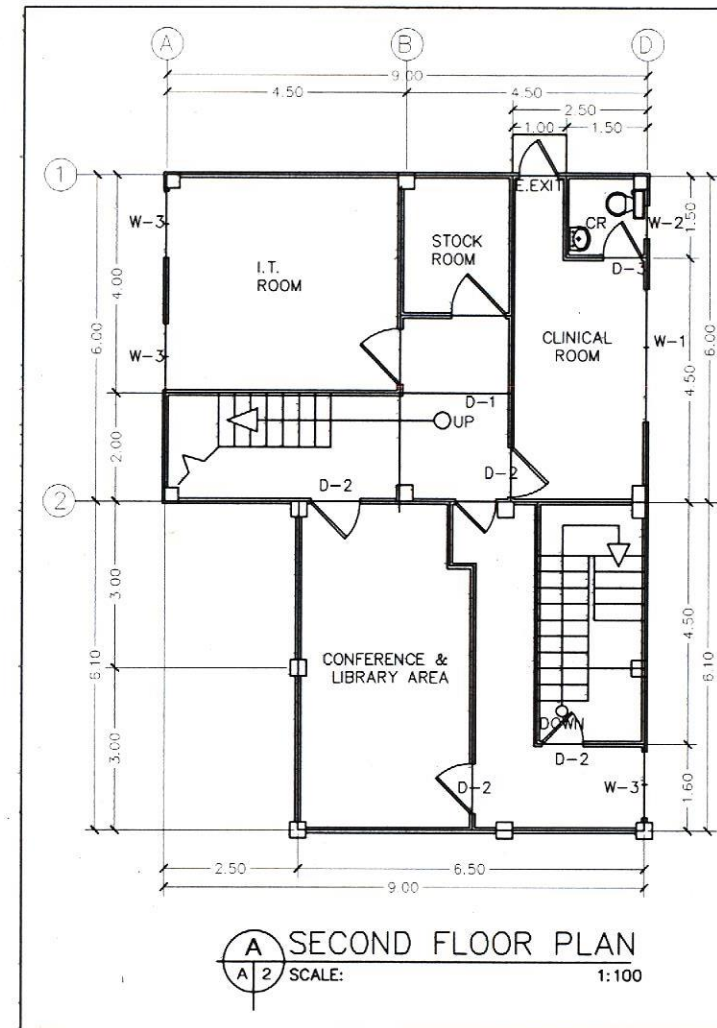
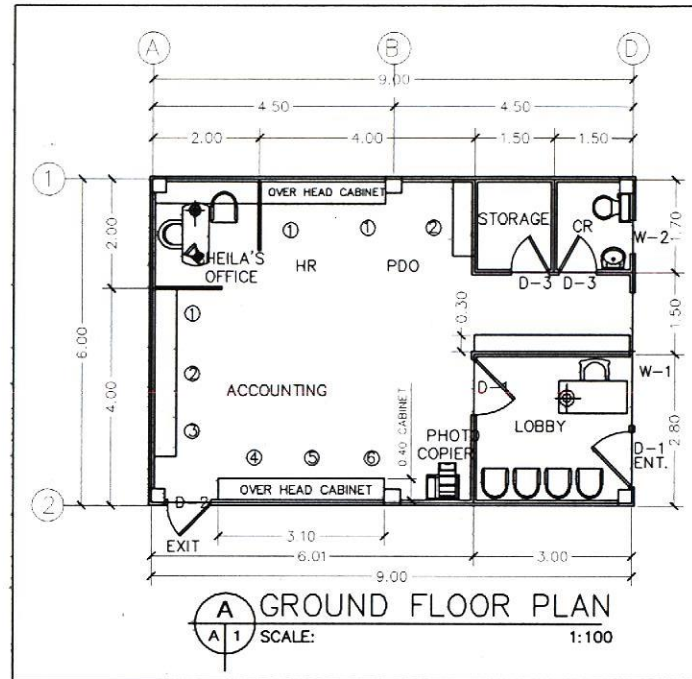



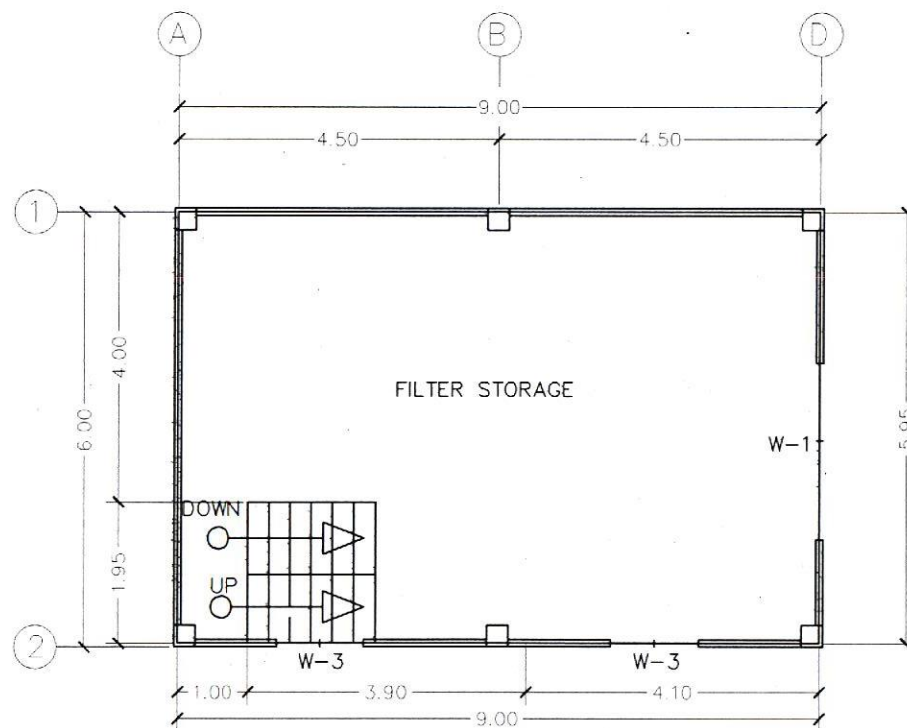
SPMC MASTER SITE DEVELOPMENT PLAN

TABLE OF CONTENTS		REPUBLIC OF THE PHILIPPINES DEPARTMENT OF PUBLIC WORKS AND HIGHWAYS
SHEET NO.	SHEET TITLE	OFFICE OF THE BUILDING OFFICIAL
		DAVAO CITY
		LAND USE & ZONING
		LINE AND GRADE
		ARCHITECTURAL
		STRUCTURAL
		SANITARY
		ELECTRICAL
		MECHANICAL


 <p>Republic of the Philippines DEPARTMENT OF HEALTH</p> <p>SOUTHERN PHILIPPINES MEDICAL CENTER</p> <p>J.P. Laurel Avenue, Baguio, Davao City</p>	PREPARED BY _____ RA 9296 SECTION 33 Drawings and specifications and other documents (hereinafter called "plans") submitted, the submission of which, with the indicated property and the submission of the certificate, shall be subject to the approval of the Department of Health, and the Department of Health shall be responsible for the approval of the plans and the submission of the certificate.		PROJECT TITLE <p>PROPOSED 3 STOREY N.B.S OFFICE EXTENSION</p>		CHECKED BY <p>HENRY Q. TANCIO SPMC - ENGINEER N</p>		RECOMMENDING APPROVAL <p>RICARDO B. ALDAN, MD, FRAFP DHC - MEDICAL CENTER CHIEF II SOUTHERN PHILIPPINES MEDICAL CENTER</p>		APPROVED BY _____ SHEET NO. <p>A - 1</p>	
	PRG REG. No. _____ Validity _____ PTR No. _____ Date: _____ Place: DAVAO CITY TIN No. _____	Validity _____ Date: _____ Place: DAVAO CITY TIN No. _____	LOCATION <p>SOUTHERN PHILIPPINES MEDICAL CENTER COMPOUND, J.P. LAUREL AVENUE, BAGUIO, DAVAO CITY</p>		PRG REG. No. 0076235 Validity Dec. 26, 2021 PTR No. _____ Date: June 15, 1996 Place: DAVAO CITY TIN No. 142-126-124				CADD BY: A.C.T CHECKED BY: _____ DATE: _____	




 <p>Republic of the Philippines DEPARTMENT OF HEALTH SOUTHERN PHILIPPINES MEDICAL CENTER J.P. Laurel Avenue, Bago, Davao City</p>	<p>PREPARED BY</p> <p>PRC REG. No. _____ Validity _____</p> <p>PTR No. _____ Date: _____</p> <p>Place DAVAO CITY TIN No. _____</p>	<p>AS BORN SECTION 53</p> <p>Drawings and specifications and other related documents shall remain the property of the Department of Health, Southern Philippines Medical Center. No part of this drawing shall be reproduced or transmitted in any form or by any means, electronic, mechanical, photocopying, recording, or by any information storage and retrieval system, without the prior written permission of the Department of Health, Southern Philippines Medical Center. The author of this drawing is not responsible for any errors or omissions in the drawing and shall not be held liable for any damages or losses arising from the use of this drawing.</p>	<p>PROJECT TITLE</p> <p>PROPOSED 3 STOREY N.B.S OFFICE EXTENSION</p> <p>LOCATION</p> <p>SOUTHERN PHILIPPINES MEDICAL CENTER COMPOUND, J.P. LAUREL AVENUE, BAGO, DAVAO CITY</p>	<p>CHECKED BY</p> <p>HENRY A. TANCIO SPAC ENGINEER IV</p> <p>PRC REG. No. 0076235 Validity Dec. 26, 2021</p> <p>PTR No. _____ Date: June 19, 1996</p> <p>Place DAVAO CITY TIN No. 142-126-124</p>	<p>RECOMMENDING APPROVAL</p> <p>RICARDO B. AUDAN, MD, FPAFP OIC - MEDICAL CENTER CHIEF II SOUTHERN PHILIPPINES MEDICAL CENTER</p>	<p>APPROVED BY</p> <p>_____</p>	<p>SHEET NO.</p> <p>A - 2</p> <p>DRAWN BY: ACT</p> <p>CHECKED BY: _____</p> <p>DATE: _____</p>
---	--	--	--	---	---	---------------------------------	--




THIRD FLOOR PLAN
SCALE: 1:100

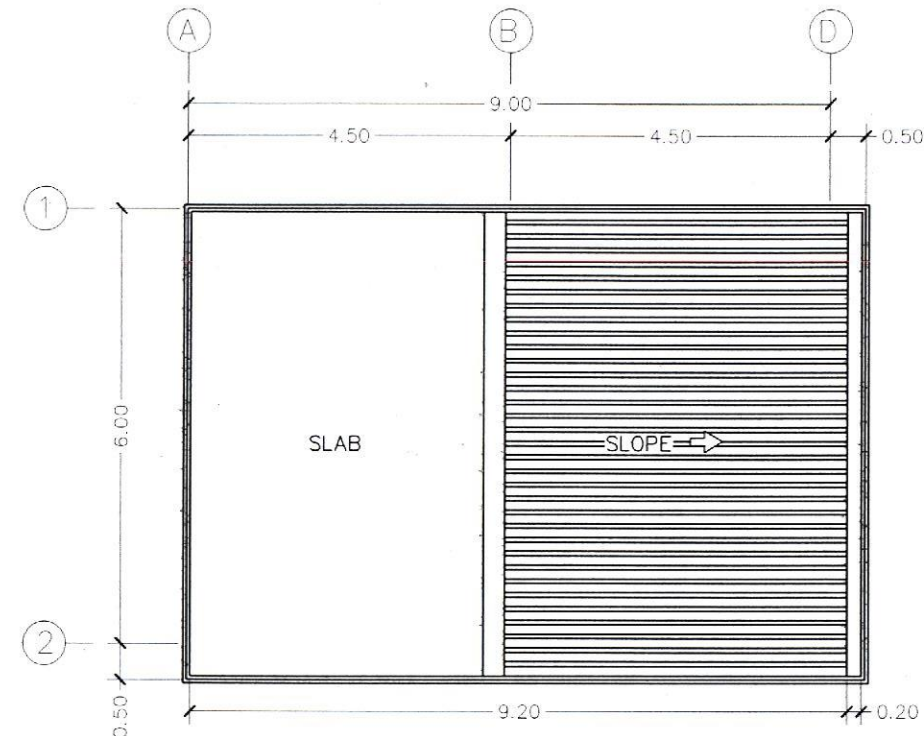


ROOF PLAN
SCALE: 1:100


 <p>Republic of the Philippines DEPARTMENT OF HEALTH SOUTHERN PHILIPPINES MEDICAL CENTER J.P. Laurel Avenue, Baguio, Davao City</p>	PREPARED BY		RA 9296 SECTION 33	PROJECT TITLE	CHECKED BY	RECOMMENDING APPROVAL	APPROVED BY	SHEET NO.	
			<small>Drawings and specifications and other contract documents and details, standard or special, or otherwise of works, are the intellectual property and confidential information of the SPMC. The SPMC shall not be held responsible for any loss or damage to the SPMC or to the SPMC's employees or to the SPMC's assets or to the SPMC's reputation or to the SPMC's business or to the SPMC's operations or to the SPMC's financial position or to the SPMC's credit rating or to the SPMC's ability to obtain financing or to the SPMC's ability to perform its obligations or to the SPMC's ability to carry out its functions or to the SPMC's ability to provide its services or to the SPMC's ability to maintain its facilities or to the SPMC's ability to protect its information or to the SPMC's ability to ensure the security of its facilities or to the SPMC's ability to ensure the safety of its employees or to the SPMC's ability to ensure the safety of the public or to the SPMC's ability to ensure the safety of the environment or to the SPMC's ability to ensure the safety of the community or to the SPMC's ability to ensure the safety of the world.</small>	PROPOSED 3 STOREY N.B.S OFFICE EXTENSION	HENRY O. TANCIO SPMC - ENGINEER III				A - 3
	PRC REG. No.	Validity	LOCATION	PRC REG. No.	Validity	RICARDO B. AUDAN, MD, FPAFP OIC - MEDICAL CENTER CHIEF II SOUTHERN PHILIPPINES MEDICAL CENTER			<small>Drawn BY: A.C.T. Checked BY: Date:</small>
	PTR No.	Date:	SOUTHERN PHILIPPINES MEDICAL CENTER COMPOUND, J.P. LAUREL AVENUE, BAGUIO, DAVAO CITY	PTR No.	Date:				
Place	DAVAO CITY	TIN No.		Place	DAVAO CITY	TIN No.	142-126-124		

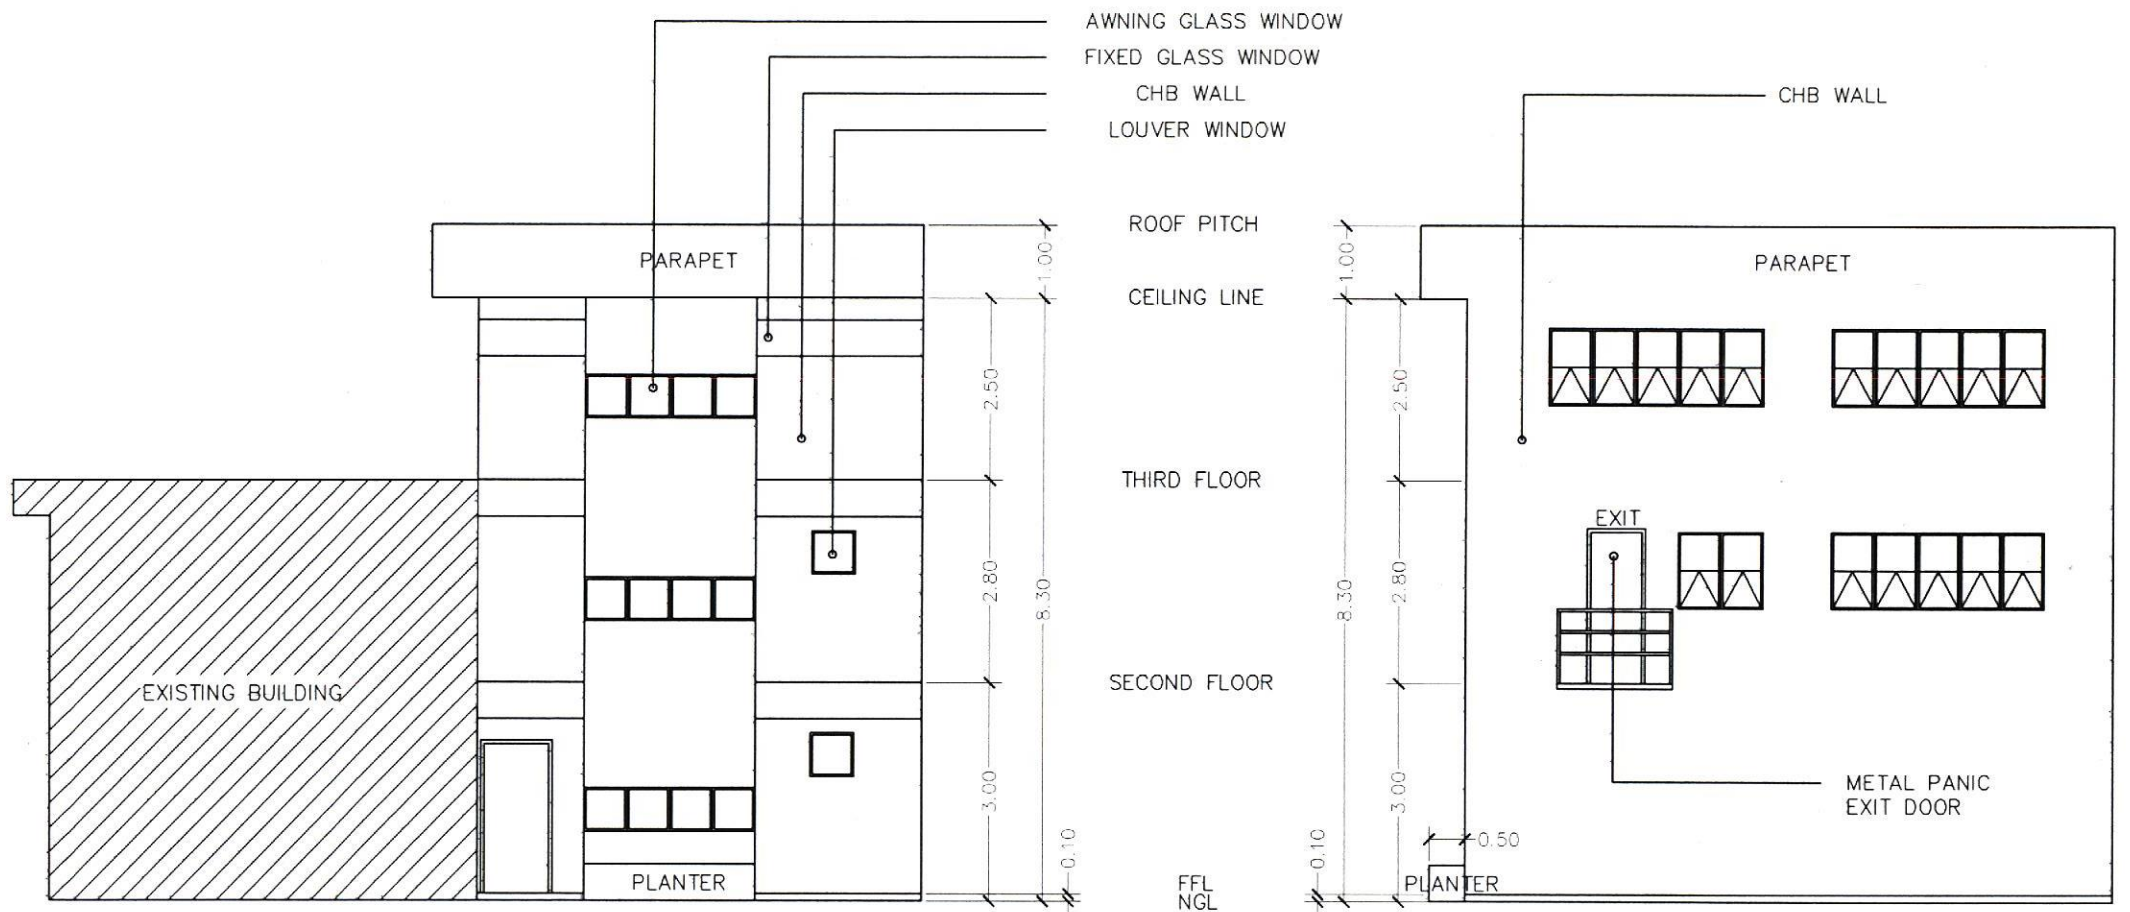

A
A 1 FRONT ELEVATION
SCALE: 1:100


A
A 2 RIGHT ELEVATION
SCALE: 1:100


 <p>Republic of the Philippines DEPARTMENT OF HEALTH SOUTHERN PHILIPPINES MEDICAL CENTER J.P. Laurel Avenue, Baguio, Davao City</p>	<p>PREPARED BY</p> <p>PRC REG. No. _____ Validity _____</p> <p>PTR No. _____ Date: _____</p> <p>Place: DAVAO CITY TIN No. _____</p>	<p>AS BORN SECTION 33</p> <p>Knowledge and competence and other essential requirements and standards of practice, as determined by the Board of Medical Education of the Philippines, shall be the basis for the issuance of the PRC REG. No. and the validity thereof.</p>	<p>PROJECT TITLE</p> <p>PROPOSED 3 STOREY N.B.S OFFICE EXTENSION</p> <p>LOCATION</p> <p>SOUTHERN PHILIPPINES MEDICAL CENTER COMPOUND J.P. LAUREL AVENUE, BAGUIO, DAVAO CITY</p>	<p>CHECKED BY</p> <p>HENRY Q. TANCIO SPMC - ENGINEER IV</p> <p>PRC REG. No. 0078235 Validity Dec. 26, 2021</p> <p>PTR No. _____ Date: June 19, 1996</p> <p>Place: DAVAO CITY TIN No. 142-126-124</p>	<p>RECOMMENDING APPROVAL</p> <p>RICARDO B. ALBAN, MD., FPAFP CMD - MEDICAL CENTER CHIEF II SOUTHERN PHILIPPINES MEDICAL CENTER</p>	<p>APPROVED BY</p>	<p>SHEET NO.</p> <p>A - 4</p> <p>CHD BY: A.C.Y.</p> <p>CHECKED BY:</p> <p>DATE:</p>
---	---	---	---	--	--	--------------------	---

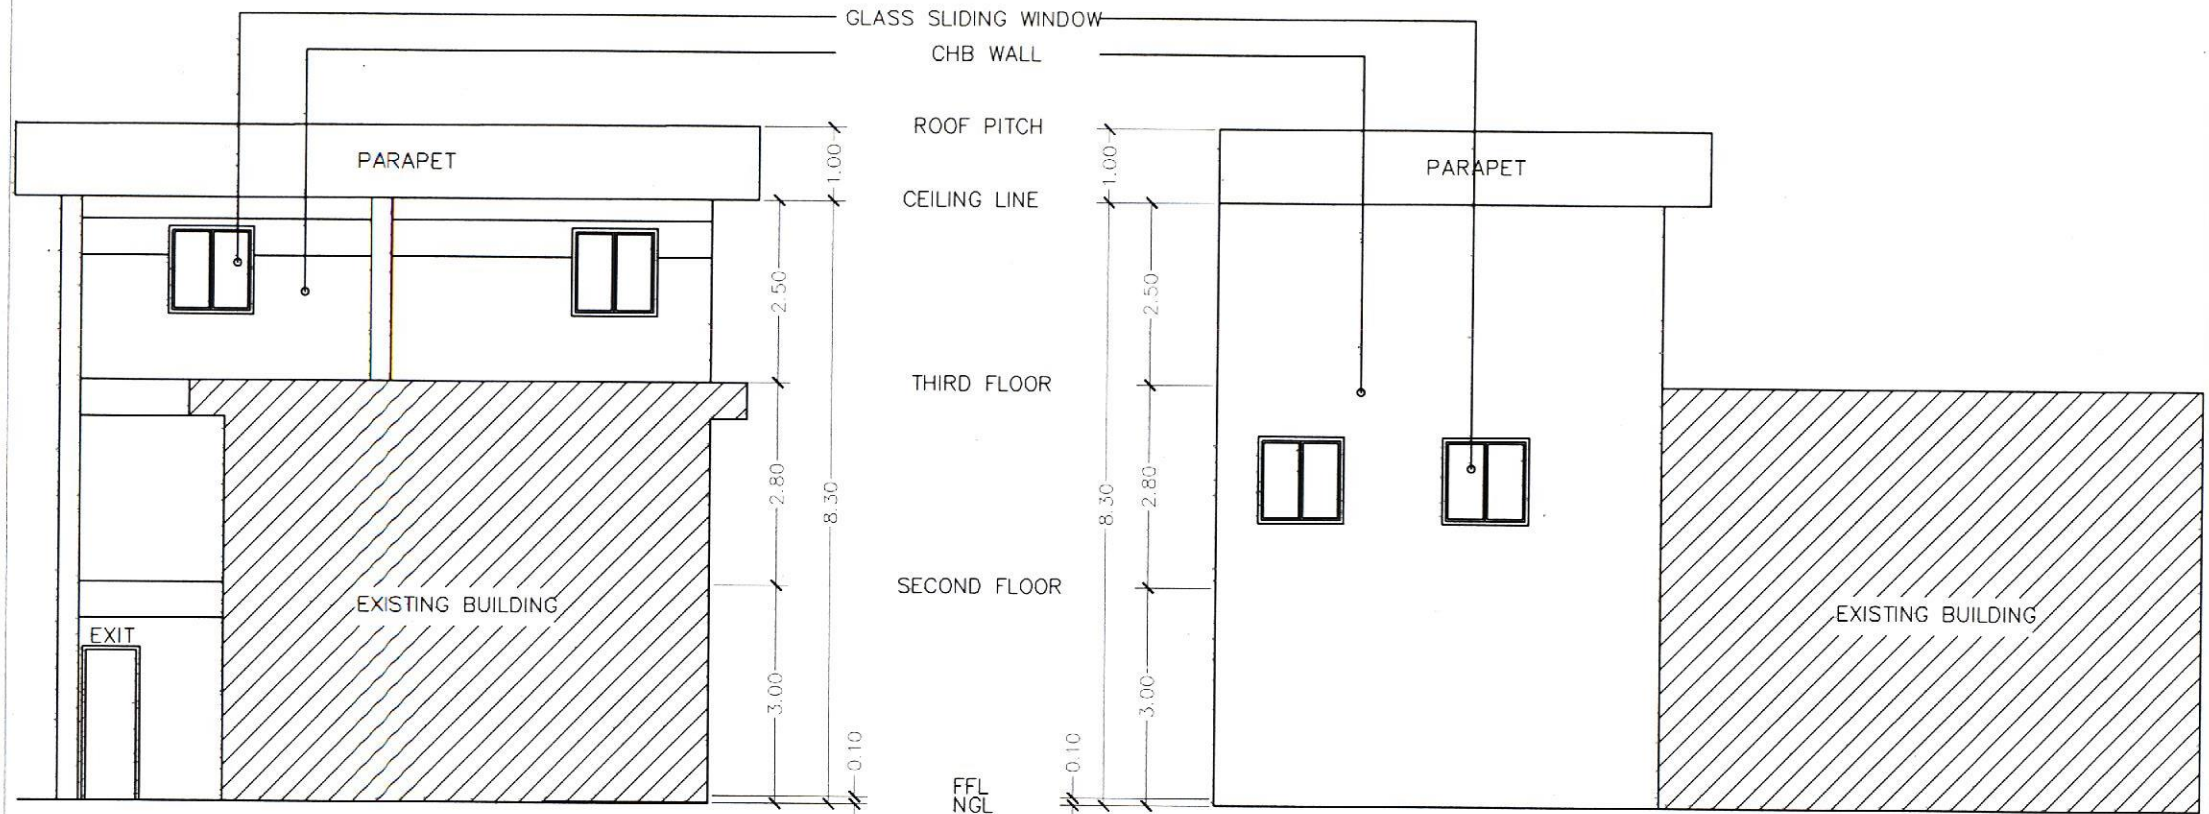


A LEFT ELEVATION
A 1 SCALE: 1:100

A REAR ELEVATION
A 2 SCALE: 1:100


 <p>Republic of the Philippines DEPARTMENT OF HEALTH SOUTHERN PHILIPPINES MEDICAL CENTER J.P. Laurel Avenue, Bujada, Davao City</p>	<p>PREPARED BY</p> <p>PRC REG. No. _____ Validity _____ PTR No. _____ Date _____ Place DAVAO CITY TIN No. _____</p>	<p>RA 9296 SECTION 33</p> <p>Drawings and specifications and other documents shall be prepared, executed, and submitted to the proper authority for approval and execution of the project, including the final design and construction of the project, and shall be subject to the review and approval of the proper authority.</p>	<p>PROJECT TITLE</p> <p>PROPOSED 3 STOREY N.B.S OFFICE EXTENSION</p> <p>LOCATION</p> <p>SOUTHERN PHILIPPINES MEDICAL CENTER COMPOUND, J.P. LAUREL AVENUE, BUJADA, DAVAO CITY</p>	<p>CHECKED BY</p> <p>HENRY O. FANCIO SPMC - ENGINEER IV</p> <p>PRC REG. No. 0076235 Validity Dec. 26, 2021 PTR No. _____ Date June 19, 1996 Place DAVAO CITY TIN No. 142-126-124</p>	<p>RECOMMENDING APPROVAL</p> <p>RICARDO B. AUDAN, MD, FPAFP CMC - MEDICAL CENTER CHIEF - II SOUTHERN PHILIPPINES MEDICAL CENTER</p>	<p>APPROVED BY</p>	<p>SHEET NO.</p> <p>A - 5</p> <p>DRAWN BY: A.C.T. CHECKED BY: DATE:</p>
---	---	---	--	--	---	--------------------	---

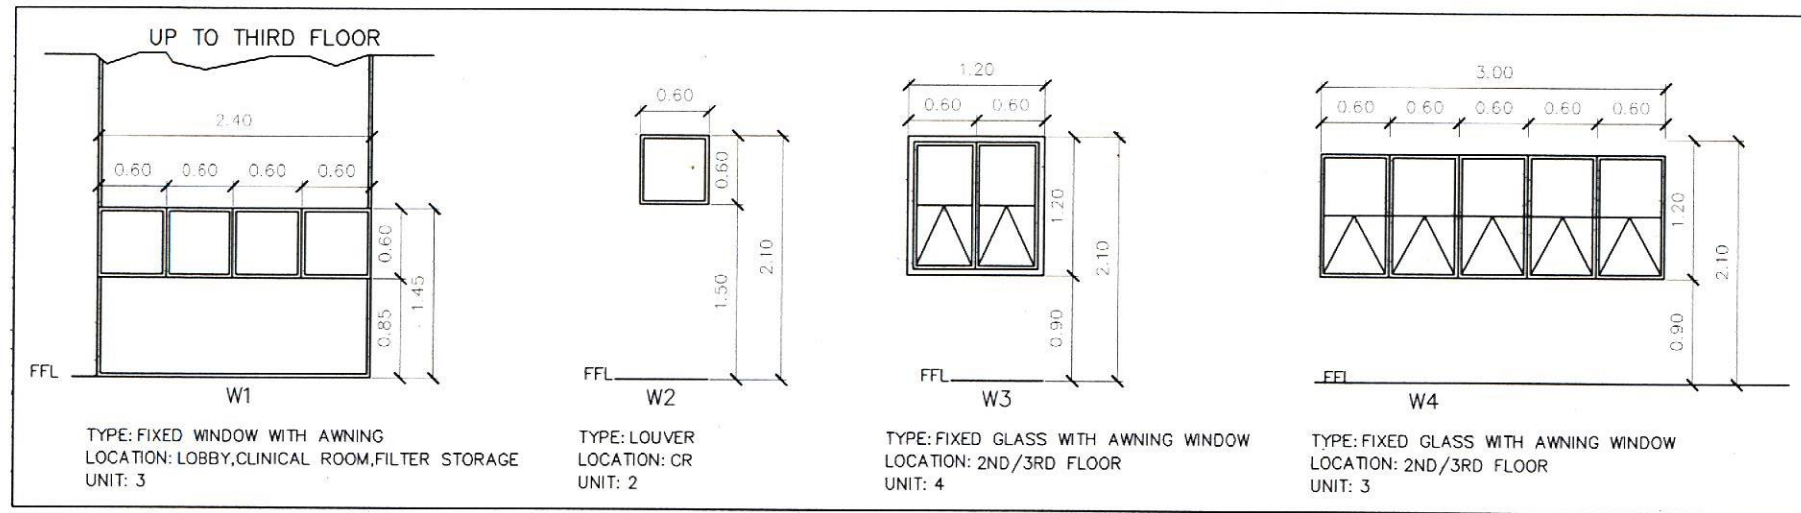

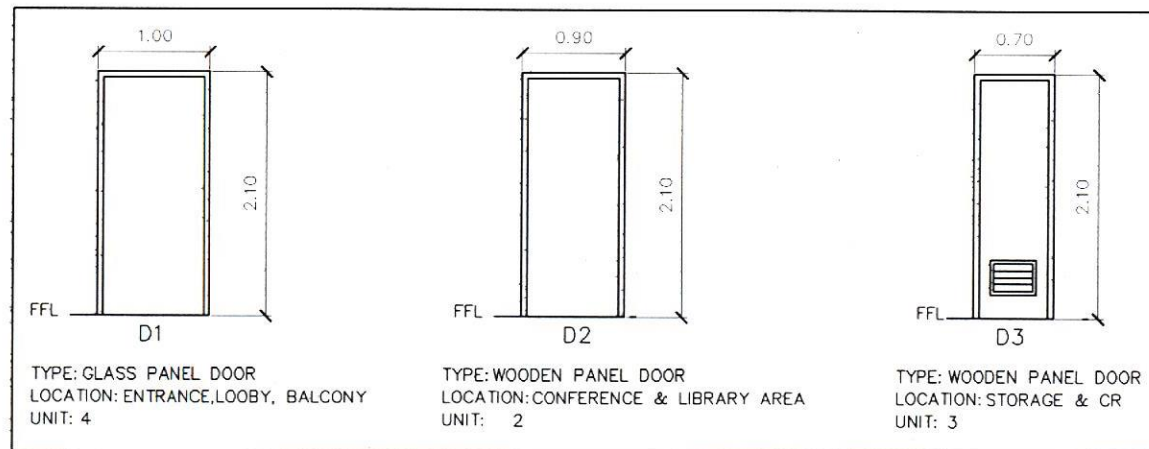


A WINDOW DETAIL
SCALE: 1:50

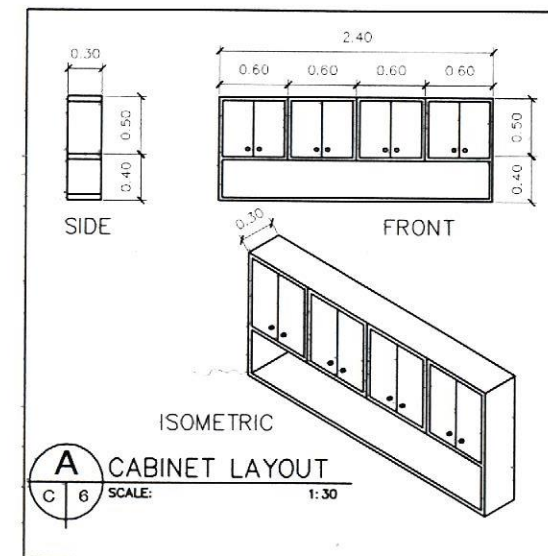


A DOOR DETAIL
SCALE: 1:50




 <div>Republic of the Philippines DEPARTMENT OF HEALTH SOUTHERN PHILIPPINES MEDICAL CENTER J.P. Laurel Avenue, Baguio, Davao City</div>	PREPARED BY		RA 9296 SECTION 23	PROJECT TITLE	CHECKED BY	RECOMMENDING APPROVAL	APPROVED BY	SHEET NO.
			Drawings and specifications and other technical documents are prepared, checked or revised, and instruments of service, on the technical property and documents of the ARCHITECT, whether the signed for which they are made is executed or not, I will be held responsible for any errors or omissions or for any other reasons in connection with the execution of the work, and I will be held responsible for any other reasons in connection with the execution of the work, and I will be held responsible for any other reasons in connection with the execution of the work.	PROPOSED 3 STOREY N.B.S OFFICE EXTENSION	HENRY O. TANCIO SPMC - ENGINEER IV	 RICARDO B. AMBAN, MD, FPAFP OC - MEDICAL CENTER CHIEF II SOUTHERN PHILIPPINES MEDICAL CENTER		A - 6
	PRC REG. No.	Validity	LOCATION	PRC REG. No.	Validity			
	PTIR No.	Date:	SOUTHERN PHILIPPINES MEDICAL CENTER COMPOUND, J.P. LAUREL AVENUE, BAGUIO, DAVAO CITY	PTIR No.	Date:			
	Place	Davao City	J.P. LAUREL AVENUE, BAGUIO, DAVAO CITY	Place	Davao City			

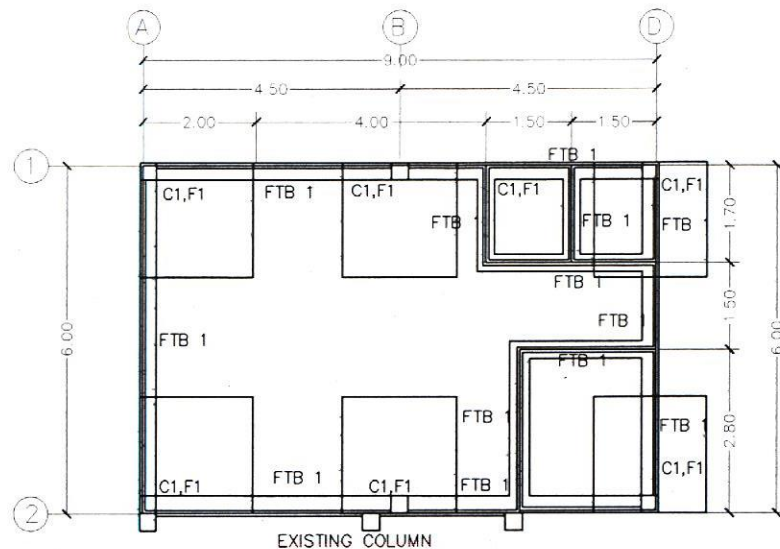


S
S 1 FOUNDATION PLAN
SCALE: 1:100

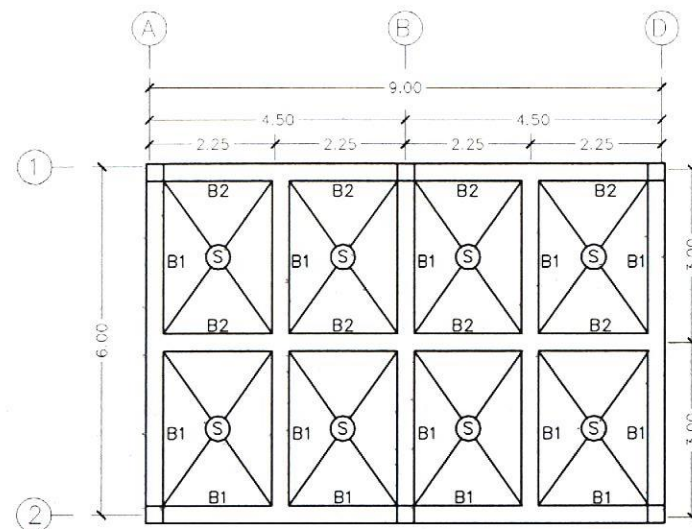


S
S 2 SECOND FLOOR BEAM PLAN
SCALE: 1:100

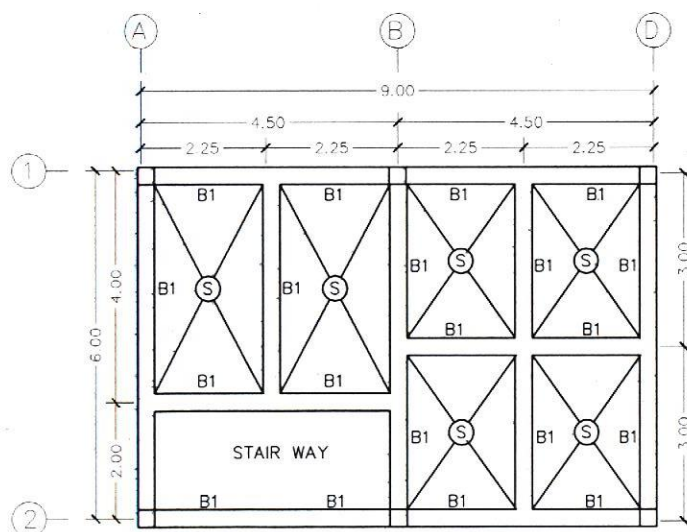


S
S 3 THIRD FLOOR BEAM PLAN
SCALE: 1:100

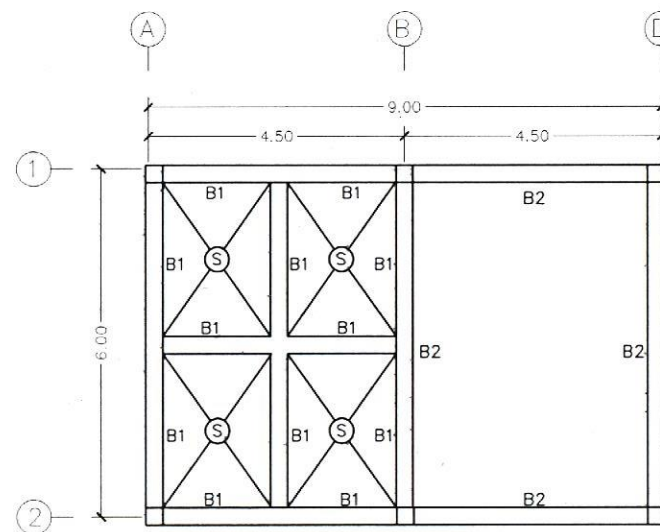


S
S 4 ROOF BEAM PLAN
SCALE: 1:100


 <p>Republic of the Philippines DEPARTMENT OF HEALTH SOUTHERN PHILIPPINES MEDICAL CENTER J.P. Laurel Avenue, Bujada, Davao City</p>	PREPARED BY	RA 9296 SECTION 33	PROJECT TITLE	CHECKED BY	RECOMMENDING APPROVAL	APPROVED BY	SHEET NO.
			PROPOSED 3 STOREY N.B.S OFFICE EXTENSION	HENRY O. TANCIO SAC - ENGINEER III			S - 1
	PRC REG. No.	Validity	LOCATION	PRC REG. No.	Validity	DATE	DATE
	PTIR No.	Date	SOUTHERN PHILIPPINES MEDICAL CENTER COMPOUND, J.P. LAUREL AVENUE, BUJADA, DAVAO CITY	PTIR No.	Date	DATE	DATE

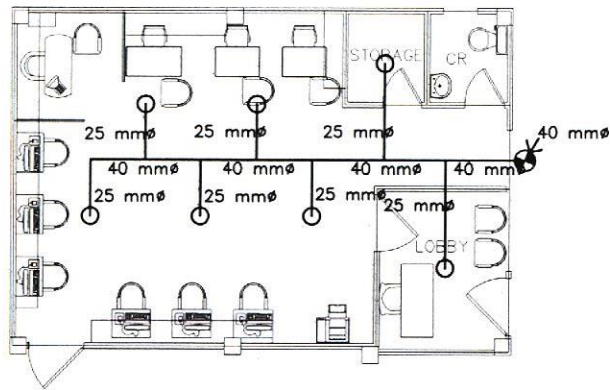


P 1 GROUND FLOOR SPRINKLER PLAN
SCALE: 1:100

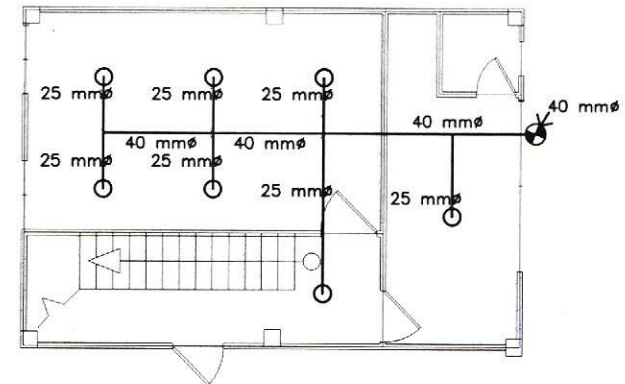


P 2 SECOND FLOOR SPRINKLER PLAN
SCALE: 1:100

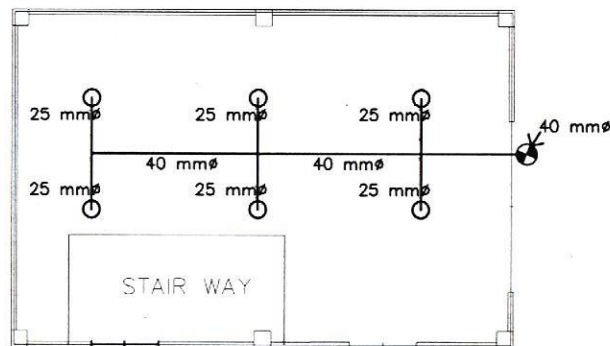


P 3 THIRD FLOOR SPRINKLER PLAN
SCALE: 1:100

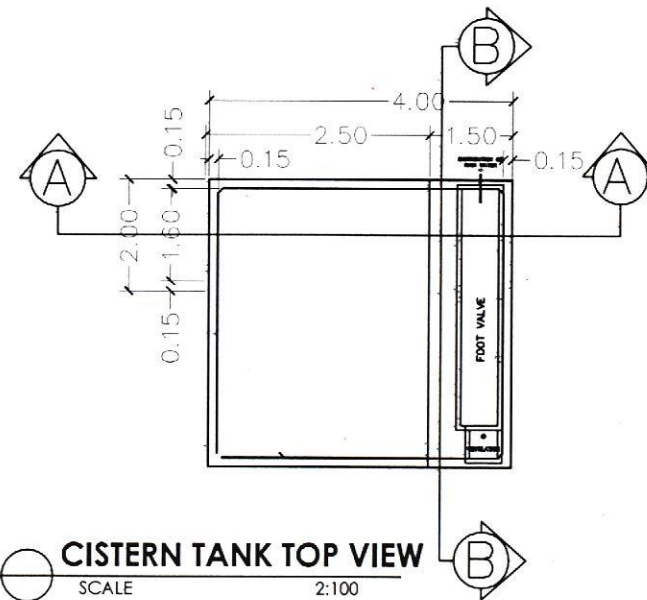


CISTERN TANK TOP VIEW
SCALE: 2:100

 <p>Republic of the Philippines DEPARTMENT OF HEALTH SOUTHERN PHILIPPINES MEDICAL CENTER J.P. Laurel Avenue, Baguio, Davao City</p>	PREPARED BY		RA 5996 SECTION 33	PROJECT TITLE		CHECKED BY	RECOMMENDING APPROVAL	APPROVED BY	SHEET NO.
			Knowledge and qualifications and other pertinent documents duly signed, stamped or sealed, as indicated of notice, on the indicated property and documents of the ENGINEER, whether the design for which they are made is covered or not, I shall not be held responsible for any errors in substance or in any other respects of buildings, whether covered partly or in whole, without the written consent of the ENGINEER. I shall, nevertheless, be liable for all damages, damages and other liabilities of these matters.	PROPOSED 3 STOREY N.B.S OFFICE EXTENSION		HENRY C. TANCIO SPMC-ENGINEER IV			P - 1
	PRIC REG. No.		Validity	LOCATION		PRIC REG. No.	Validity	RICARDO B. ADDAN, MD, FPAP OIC - MEDICAL CENTER CHIEF II SOUTHERN PHILIPPINES MEDICAL CENTER	DRAWN BY: ACT CHECKED BY: DATE:
	PTR No.		Date:	SOUTHERN PHILIPPINES MEDICAL CENTER COMPOUND, J.P. LAUREL AVENUE, BAGUIO, DAVAO CITY		0078235	Dec. 28, 2021		
	Place		Davao City			Place	Davao City		
			TIN No.				TIN No.		
							142-126-124		




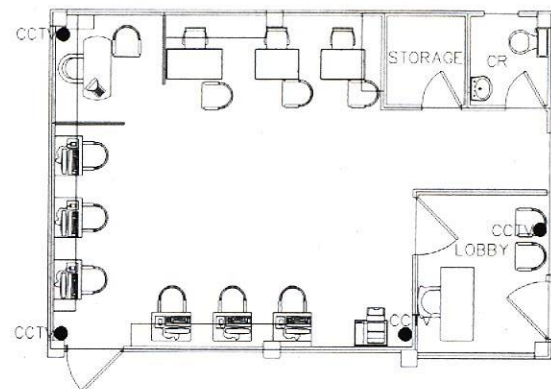

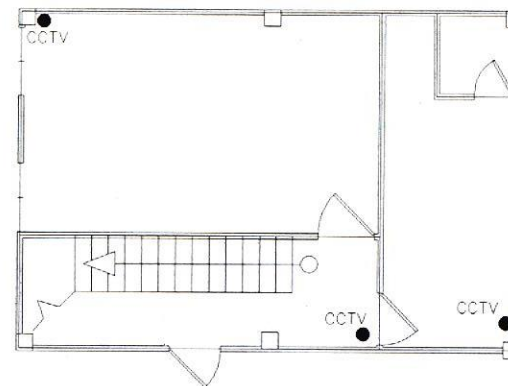

E
E 1 GROUND FLOOR CCTV PLAN
SCALE: 1:100

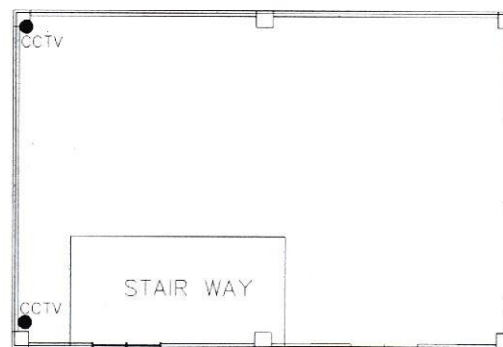


E
E 1 SECOND FLOOR CCTV PLAN
SCALE: 1:100



E
E 1 THIRD FLOOR CCTV PLAN
SCALE: 1:100

 <p>Republic of the Philippines DEPARTMENT OF HEALTH SOUTHERN PHILIPPINES MEDICAL CENTER J.P. Laurel Avenue, Baljoda, Davao City</p>	PREPARED BY		RA 9296 SECTION 33	PROJECT TITLE	CHECKED BY	RECOMMENDING APPROVAL	APPROVED BY	SHEET NO.	
			<small>Drawings and specifications and other documents shall remain the property of the Department of Health, and shall not be used for any other purpose without the written consent of the Department of Health. The Department of Health shall not be held responsible for any errors or omissions in the drawings and specifications and other documents.</small>	PROPOSED 3 STOREY N.B.S OFFICE EXTENSION	HENRY Q. TANCIO SPAC - ENGINEER IV	 <p>RICARDO B. JORDAN, MD, FPAFP OIC - MEDICAL CENTER CHIEF II SOUTHERN PHILIPPINES MEDICAL CENTER</p>		E - 1	
	PNC REG. No.	Validity		LOCATION	PNC REG. No.		Validity	DATE	CREATED BY: ACT
	PTIR No.	Date:		SOUTHERN PHILIPPINES MEDICAL CENTER COMPOUND, J.P. LAUREL AVENUE, BALJODA, DAVAO CITY	PTIR No.		Date:	DATE	CHECKED BY:
Place	DIVISION CITY	TIN No.			Place	DIVISION CITY	TIN No.		

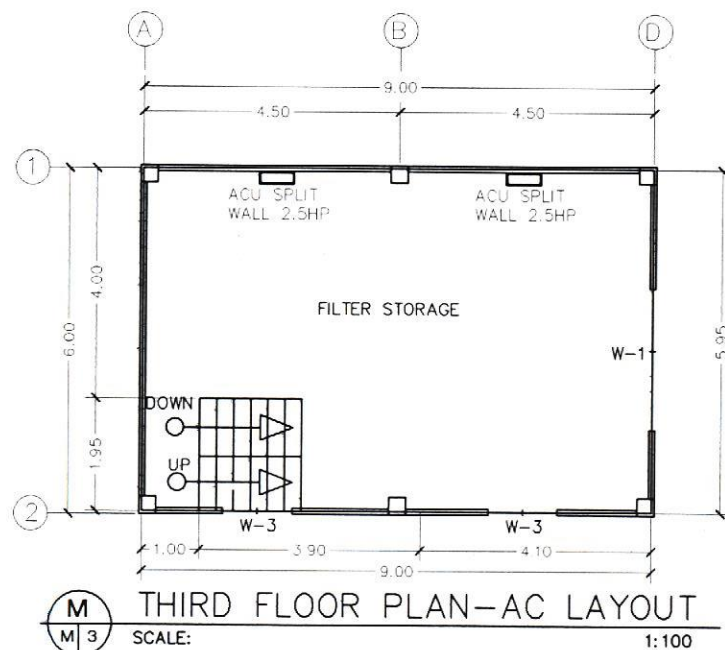

Republic of the Philippines
DEPARTMENT OF HEALTH
SOUTHERN PHILIPPINES
MEDICAL CENTER

L.P. Laurel Avenue, Bajada, Davao City

[illegible]